



# BOLAHUNWORLDWIDE- USA ST. AGNES RECONSTRUCTION PROJECT

- Bolahunworldwide USA
- 145 Noble Beach Drive
- Euclid Ohio 44123
- Email: Bolahunworldwide@gmail.com
- Website: [www.bolahunworldwide.com](http://www.bolahunworldwide.com)

Project Overview:  
When completed  
the school will  
have:

Classrooms from the Pre-K to 6th Grade

Cafeteria/Auditorium

Computer Lab

Library

Generator Room

Four Rest Rooms

Teachers' Lounge

Principals' Office

Science Lab

Storage Room



Project Objectives:

Provide

Provide an affordable, conducive and safe learning environment for students from Bolahun, the surrounding villages, and other parts of Liberia

Serve

Serve as Feeder program for the high school in Bolahun and other schools in Liberia

Prepare

Prepare students to excel and become competitive

Expose

Expose students to modern technology such as computers and the internet

Create

Create positive outcomes and restore academic excellence in Bolahun



PROJECT LOCATION:

Bolahun City  
Wanhashah District  
Lofa County  
Republic Of Liberia

PLOT SCALE N / A

Drawing Provide By

DRAWN  
DESIGNED:  
ARCHITECT

Trust Management  
Construction Group

CLIENTS:

Bolahunworldwide- USA  
St. Agnes Reconstruction Project

DWG. TITLE:

COVER PAGE

F.A./RTE

SECTION

Date : November 2 ,2024

TOTAL SHEETS

SHEET NO.

NOTE:

ALL DIMENSIONS ARE IN FEET & INCHES  
AND SHOULD BE VERIFIED ON THE SITE

20

1



| PROJECT LOCATION:                                                        | PLOT SCALE |                                        | N / A | Drawing Provide By | CLIENTS:                                                  | DWG. TITLE:                   | F.A./RTE | SECTION                                                                   | Date : November 2 ,2024 | TOTAL SHEETS | SHEET NO. |
|--------------------------------------------------------------------------|------------|----------------------------------------|-------|--------------------|-----------------------------------------------------------|-------------------------------|----------|---------------------------------------------------------------------------|-------------------------|--------------|-----------|
| Bolahun City<br>Wanhassah District<br>Lofa County<br>Republic Of Liberia | DRAWN      | Trust Management<br>Construction Group |       |                    | Bolahunworldwide- USA<br>St. Agnes Reconstruction Project | LIST OF CONSTRUCTION DRAWINGS |          |                                                                           |                         | 20           | 2         |
|                                                                          | DESIGNED:  |                                        |       |                    |                                                           |                               |          |                                                                           |                         |              |           |
|                                                                          | ARCHITECT  |                                        |       |                    |                                                           |                               | NOTE:    | ALL DIMENSIONS ARE IN FEET & INCHES<br>AND SHOULD BE VERIFIED ON THE SITE |                         |              |           |

1. COVER PAGE

2. PICTORIAL VIEWS

3. LIST OF CONSTRUCTION DRAWINGS

4. PROPOSED SITE DEVELOPMENT PLAN

5. FOUNDATION PLAN

6. FOUNDATION DETAILS

7. FLOOR PLAN

8. DOOR AND WINDOW SCHEDULES

9. TYPICAL DOOR AND WINDOW SCHEDULES

10. PLUMBING PLAN

11. PLUMBING LEGENDS

12. ELECTRICAL PLAN

13. ELECTRICAL LEGENDS

14. PANEL BOARD DIAGRAM

15. ROOF FRAMING PLAN

16. ROOF SHEETING PLAN


17. TYPICAL ROOFING DETAILS

18. LONGITUDINAL SECTION @ T - T


19. CROSS SECTION @ N - N

20. ELEVATION PLAN

|                                                                          |            |                                        |                    |                                                           |                               |          |                                                                           |                         |              |           |
|--------------------------------------------------------------------------|------------|----------------------------------------|--------------------|-----------------------------------------------------------|-------------------------------|----------|---------------------------------------------------------------------------|-------------------------|--------------|-----------|
| PROJECT LOCATION:                                                        | PLOT SCALE | N / A                                  | Drawing Provide By | CLIENTS:                                                  | DWG. TITLE:                   | F.A./RTE | SECTION                                                                   | Date : November 2 ,2024 | TOTAL SHEETS | SHEET NO. |
| Bolahun City<br>Wanhassah District<br>Lofa County<br>Republic Of Liberia | DRAWN      | Trust Management<br>Construction Group |                    | Bolahunworldwide- USA<br>St. Agnes Reconstruction Project | LIST OF CONSTRUCTION DRAWINGS |          |                                                                           |                         | 20           | 3         |
|                                                                          | DESIGNED:  |                                        |                    |                                                           |                               |          |                                                                           |                         |              |           |
|                                                                          | ARCHITECT  |                                        |                    |                                                           |                               | NOTE:    | ALL DIMENSIONS ARE IN FEET & INCHES<br>AND SHOULD BE VERIFIED ON THE SITE |                         |              |           |

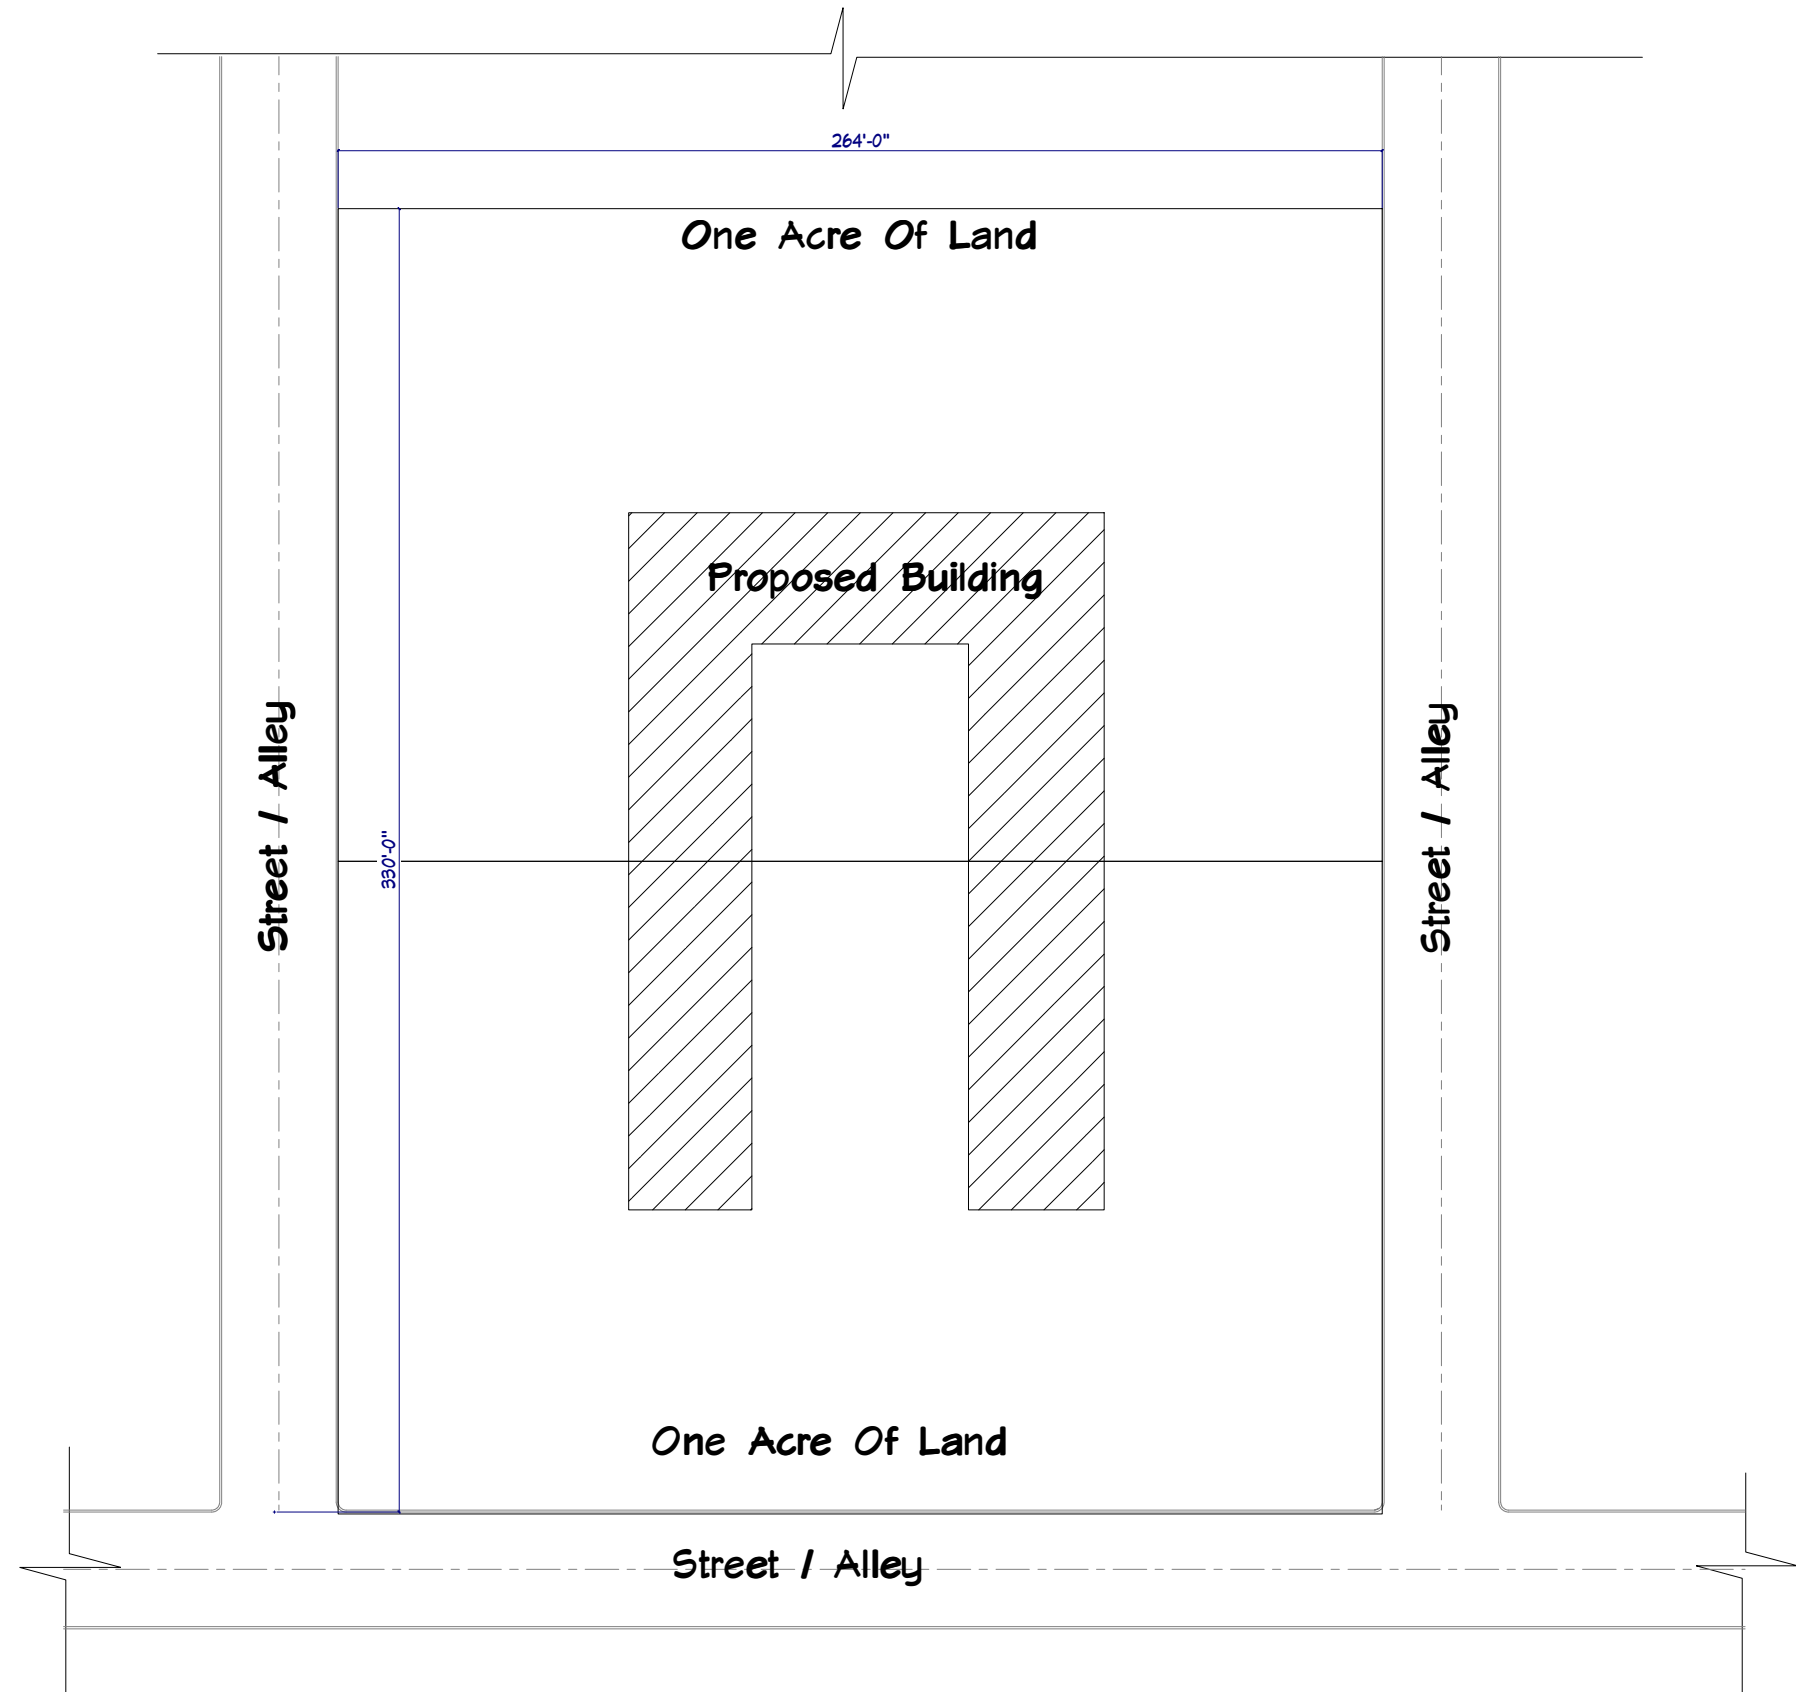


| PROJECT LOCATION:                                                        | PLOT SCALE | N / A                                  | Drawing Provide By | CLIENTS:                                                  | DWG. TITLE:                       | F.A./RTE | SECTION                                                                   | Date : November 2 ,2024 | TOTAL SHEETS | SHEET NO. |
|--------------------------------------------------------------------------|------------|----------------------------------------|--------------------|-----------------------------------------------------------|-----------------------------------|----------|---------------------------------------------------------------------------|-------------------------|--------------|-----------|
| Bolahun City<br>Wanhassah District<br>Lofa County<br>Republic Of Liberia | DRAWN      | Trust Management<br>Construction Group |                    | Bolahunworldwide- USA<br>St. Agnes Reconstruction Project | Proposed Site<br>Development Plan |          |                                                                           |                         | 20           | 4         |
|                                                                          | DESIGNED:  |                                        |                    |                                                           |                                   |          |                                                                           |                         |              |           |
|                                                                          | ARCHITECT  |                                        |                    |                                                           |                                   | NOTE:    | ALL DIMENSIONS ARE IN FEET & INCHES<br>AND SHOULD BE VERIFIED ON THE SITE |                         |              |           |

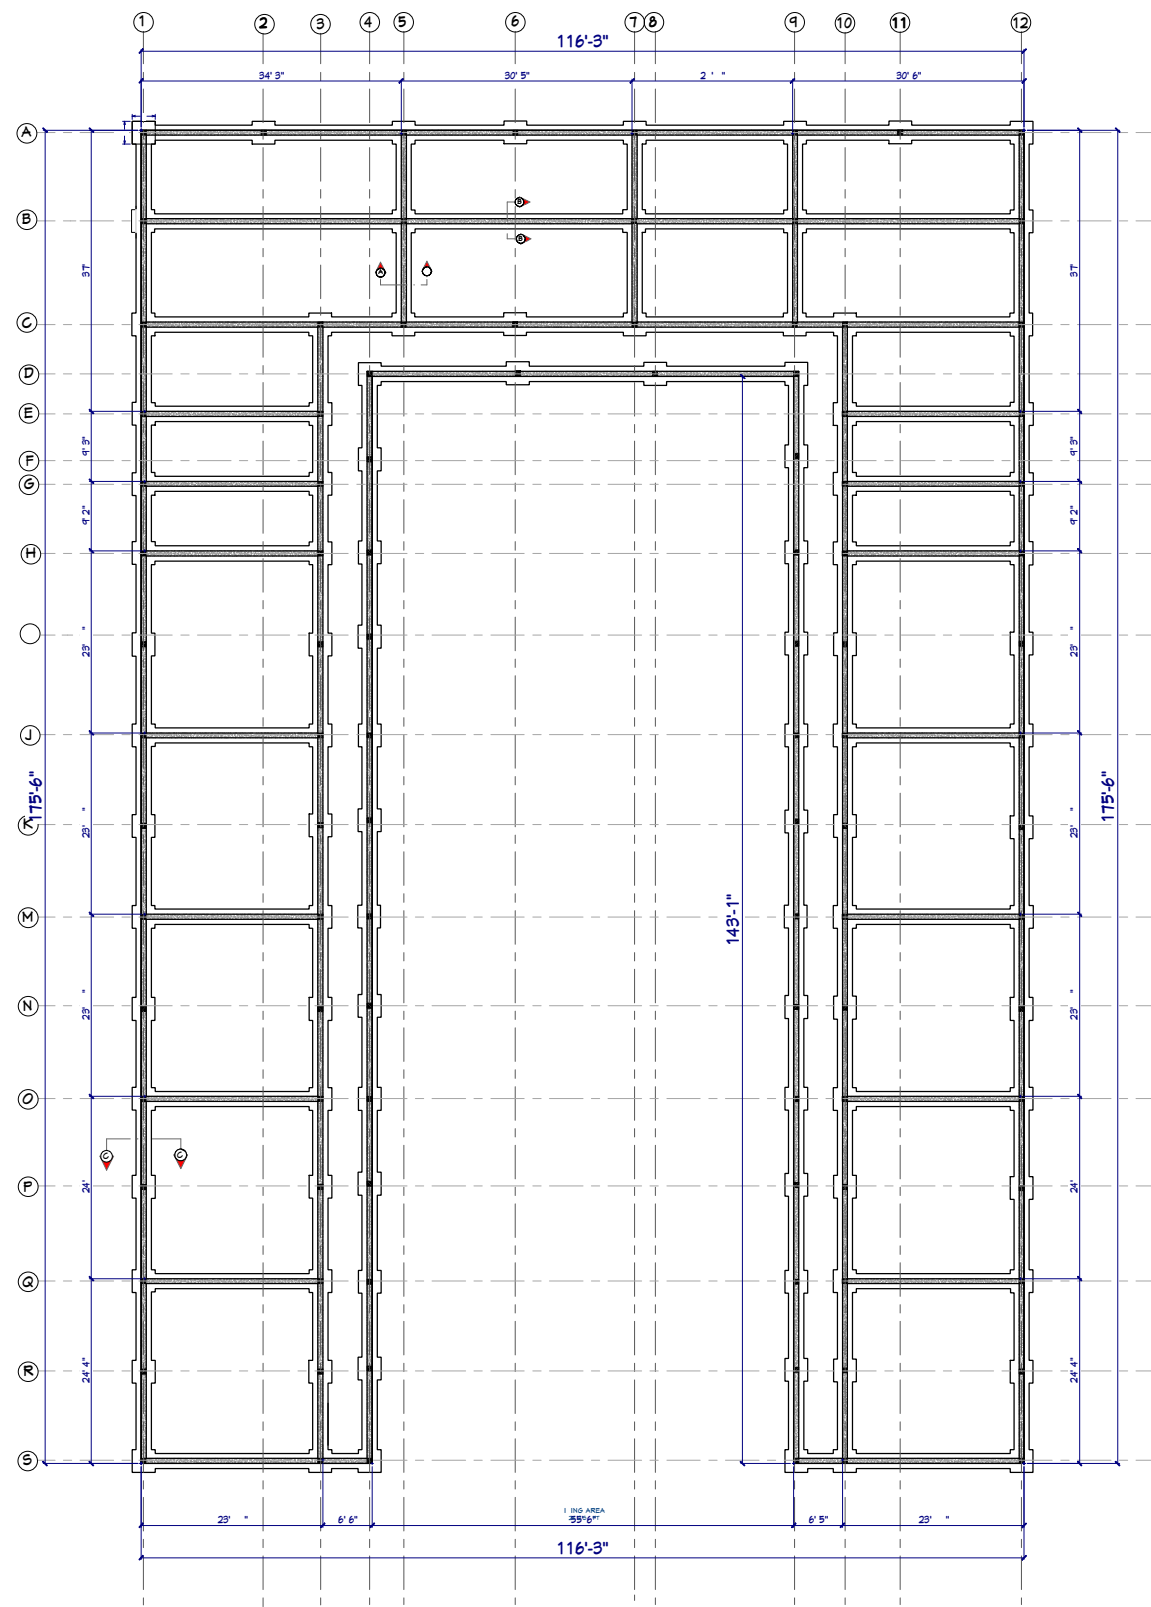


| PROJECT LOCATION:                                                        | PLOT SCALE | N / A                                  | Drawing Provide By | CLIENTS:                                                  | DWG. TITLE:     | F.A./RTE | SECTION                                                                   | Date : November 2 ,2024 | TOTAL SHEETS | SHEET NO. |
|--------------------------------------------------------------------------|------------|----------------------------------------|--------------------|-----------------------------------------------------------|-----------------|----------|---------------------------------------------------------------------------|-------------------------|--------------|-----------|
| Bolahun City<br>Wanhassah District<br>Lofa County<br>Republic Of Liberia | DRAWN      | Trust Management<br>Construction Group |                    | Bolahunworldwide- USA<br>St. Agnes Reconstruction Project | FOUNDATION PLAN |          |                                                                           |                         | 20           | 5         |
|                                                                          | DESIGNED:  |                                        |                    |                                                           |                 |          |                                                                           |                         |              |           |
|                                                                          | ARCHITECT  |                                        |                    |                                                           |                 | NOTE:    | ALL DIMENSIONS ARE IN FEET & INCHES<br>AND SHOULD BE VERIFIED ON THE SITE |                         |              |           |




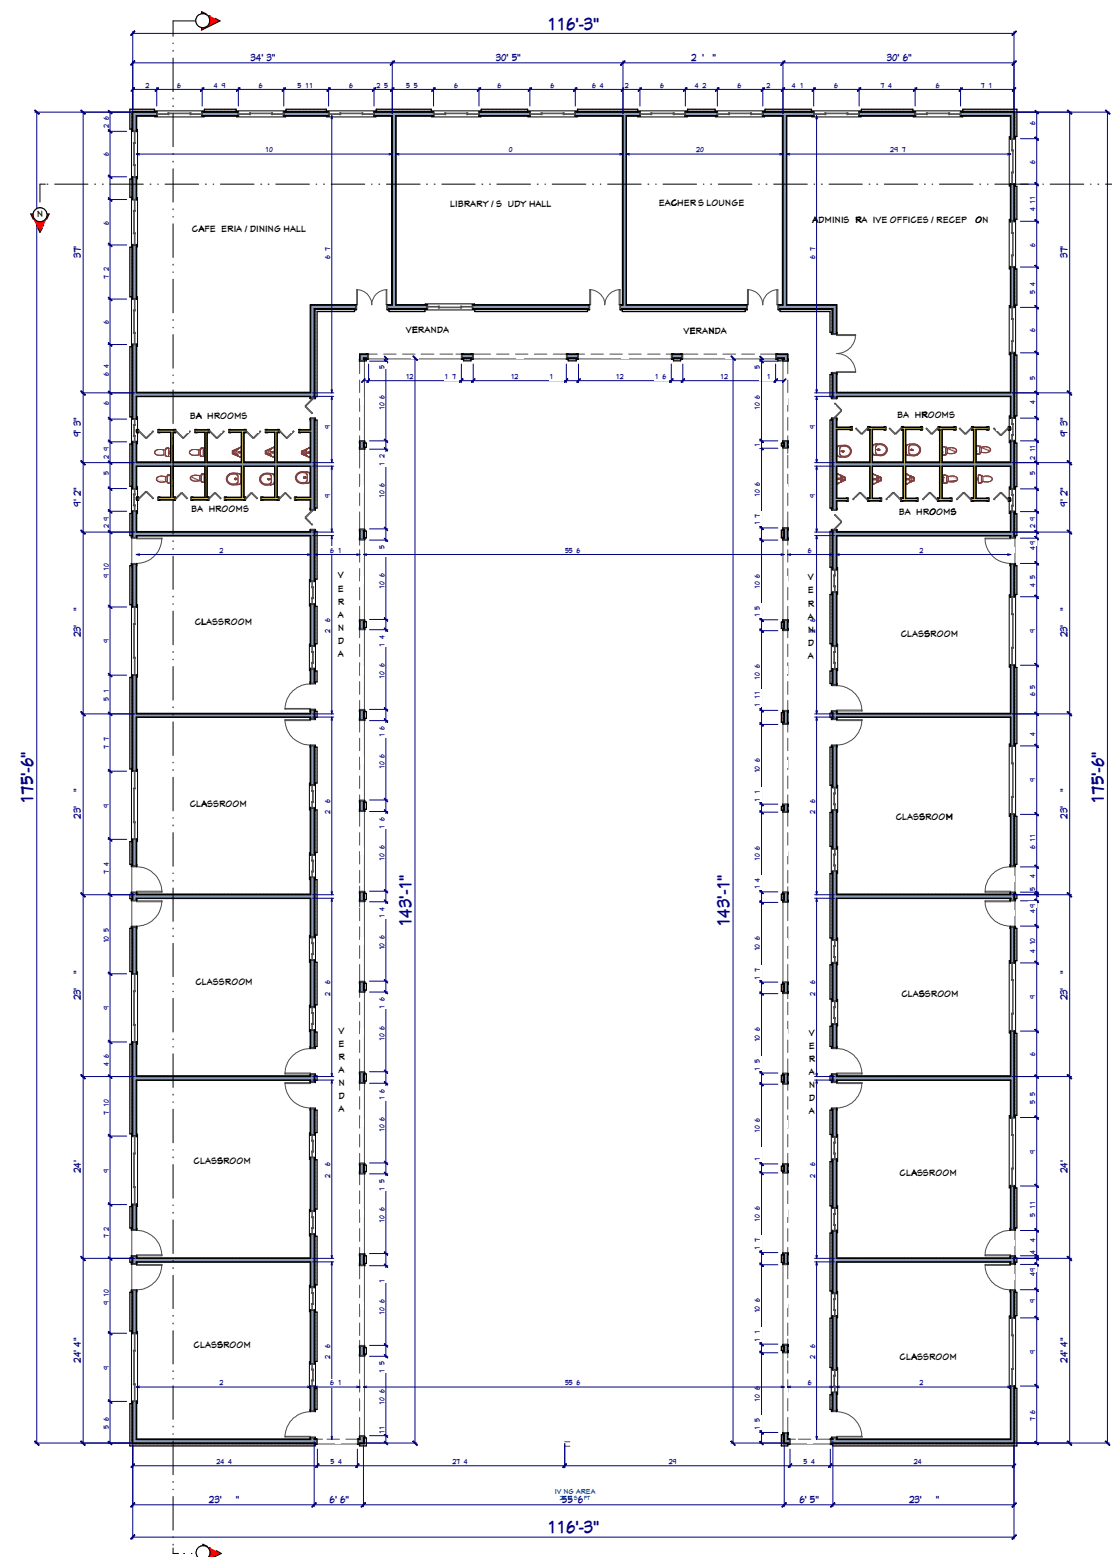


| PROJECT LOCATION:                                                        | PLOT SCALE | N / A                                  | Drawing Provide By | CLIENTS:                                                  | DWG. TITLE: | F.A./RTE | SECTION                                                                   | Date : November 2 ,2024 | TOTAL SHEETS | SHEET NO. |
|--------------------------------------------------------------------------|------------|----------------------------------------|--------------------|-----------------------------------------------------------|-------------|----------|---------------------------------------------------------------------------|-------------------------|--------------|-----------|
| Bolahun City<br>Wanhassah District<br>Lofa County<br>Republic Of Liberia | DRAWN      | Trust Management<br>Construction Group |                    | Bolahunworldwide- USA<br>St. Agnes Reconstruction Project | FLOOR PLAN  |          |                                                                           |                         | 20           | 7         |
|                                                                          | DESIGNED:  |                                        |                    |                                                           |             |          |                                                                           |                         |              |           |
|                                                                          | ARCHITECT  |                                        |                    |                                                           |             | NOTE:    | ALL DIMENSIONS ARE IN FEET & INCHES<br>AND SHOULD BE VERIFIED ON THE SITE |                         |              |           |

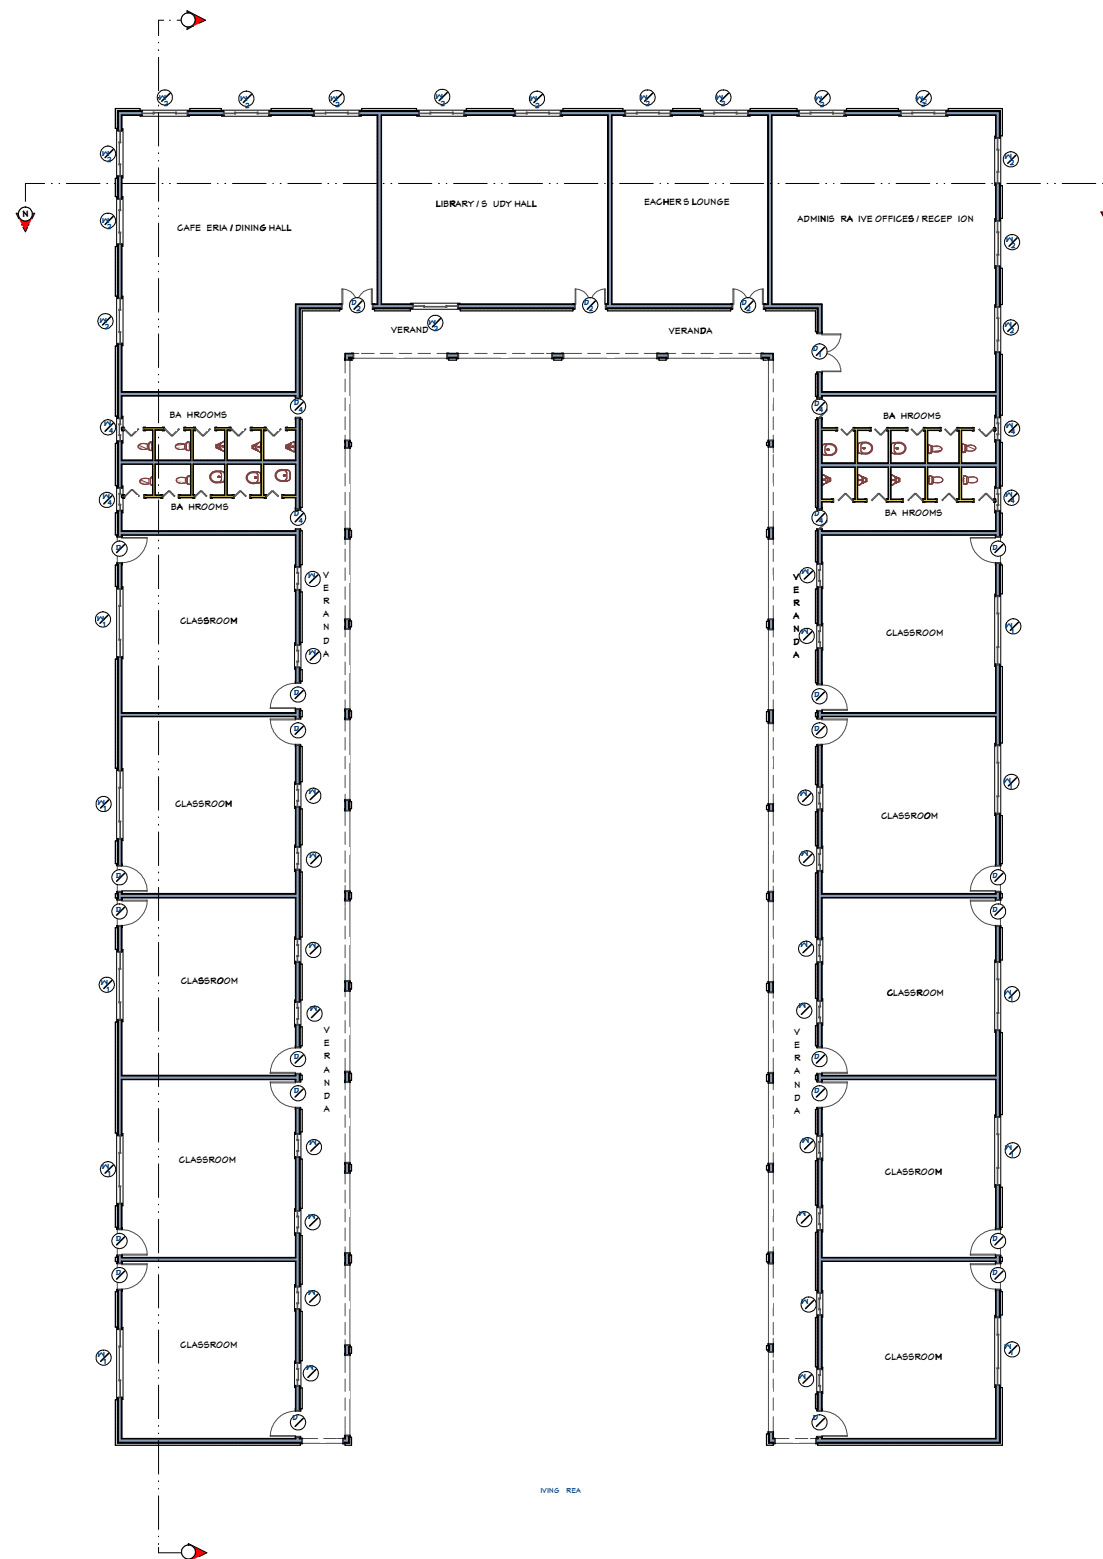

| PROJECT LOCATION:                                                        | PLOT SCALE | N / A                                  | Drawing Provide By | CLIENTS:                                                  | DWG. TITLE:                  | F.A./RTE | SECTION                                                                   | Date : November 2 ,2024 | TOTAL SHEETS | SHEET NO. |
|--------------------------------------------------------------------------|------------|----------------------------------------|--------------------|-----------------------------------------------------------|------------------------------|----------|---------------------------------------------------------------------------|-------------------------|--------------|-----------|
| Bolahun City<br>Wanhassah District<br>Lofa County<br>Republic Of Liberia | DRAWN      | Trust Management<br>Construction Group |                    | Bolahunworldwide- USA<br>St. Agnes Reconstruction Project | DOOR AND<br>WINDOW SCHEDULES |          |                                                                           |                         | 20           | 8         |
|                                                                          | DESIGNED:  |                                        |                    |                                                           |                              |          |                                                                           |                         |              |           |
|                                                                          | ARCHITECT  |                                        |                    |                                                           |                              | NOTE:    | ALL DIMENSIONS ARE IN FEET & INCHES<br>AND SHOULD BE VERIFIED ON THE SITE |                         |              |           |

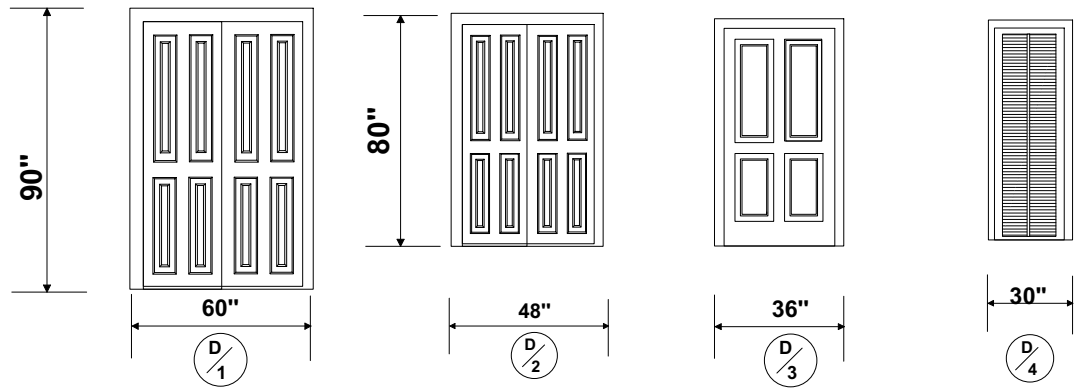


| DOOR SCHEDULE |      |       |        |          |                   |
|---------------|------|-------|--------|----------|-------------------|
| NO.           | TYPE | WIDTH | HEIGHT | QUANTITY | DESCRIPTION       |
| 1             | D/1  | 60"   | 90"    | 1        | HARDWOOD PANEL    |
| 2             | D/2  | 36"   | 80"    | 3        | HARDWOOD PANEL    |
| 3             | D/3  | 36"   | 80"    | 10       | HARDWOOD PANEL    |
| 4             | D/4  | 60"   | 80"    | 24       | JALOUSIE HARDWOOD |

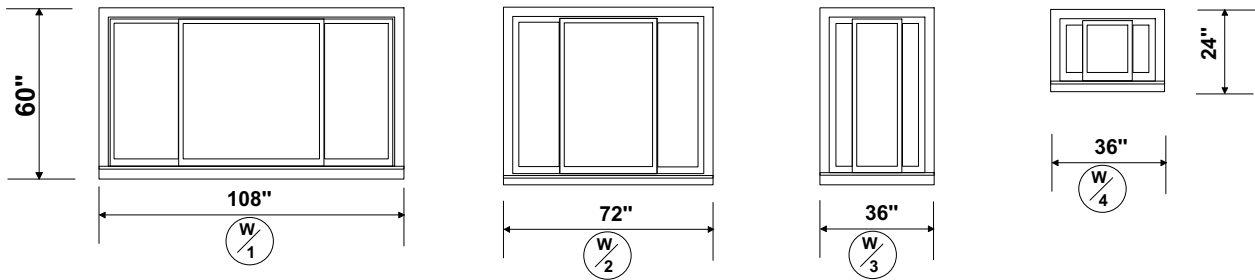



| WINDOW SCHEDULE |      |       |        |          |                               |
|-----------------|------|-------|--------|----------|-------------------------------|
| NO.             | TYPE | WIDTH | HEIGHT | QUANTITY | DESCRIPTION                   |
| 1               | W/1  | 108"  | 60"    | 10       | TRIPLE SLIDING ALUMINUM GLASS |
| 2               | W/2  | 72"   | 60"    | 15       | TRIPLE SLIDING ALUMINUM GLASS |
| 3               | W/3  | 36"   | 60"    | 20       | TRIPLE SLIDING ALUMINUM GLASS |
| 4               | W/4  | 36"   | 24"    | 4        | TRIPLE SLIDING ALUMINUM GLASS |

| PROJECT LOCATION:                                                        | PLOT SCALE | N / A                                  | Drawing Provide By | CLIENTS:                                                  | DWG. TITLE:                          | F.A./RTE | SECTION                                                                   | Date : November 2 ,2024 | TOTAL SHEETS | SHEET NO. |
|--------------------------------------------------------------------------|------------|----------------------------------------|--------------------|-----------------------------------------------------------|--------------------------------------|----------|---------------------------------------------------------------------------|-------------------------|--------------|-----------|
| Bolahun City<br>Wanhassah District<br>Lofa County<br>Republic Of Liberia | DRAWN      | Trust Management<br>Construction Group |                    | Bolahunworldwide- USA<br>St. Agnes Reconstruction Project | TYPICAL DOOR AND<br>WINDOW SCHEDULES |          |                                                                           |                         | 20           | 9         |
|                                                                          | DESIGNED:  |                                        |                    |                                                           |                                      |          |                                                                           |                         |              |           |
|                                                                          | ARCHITECT  |                                        |                    |                                                           |                                      | NOTE:    | ALL DIMENSIONS ARE IN FEET & INCHES<br>AND SHOULD BE VERIFIED ON THE SITE |                         |              |           |

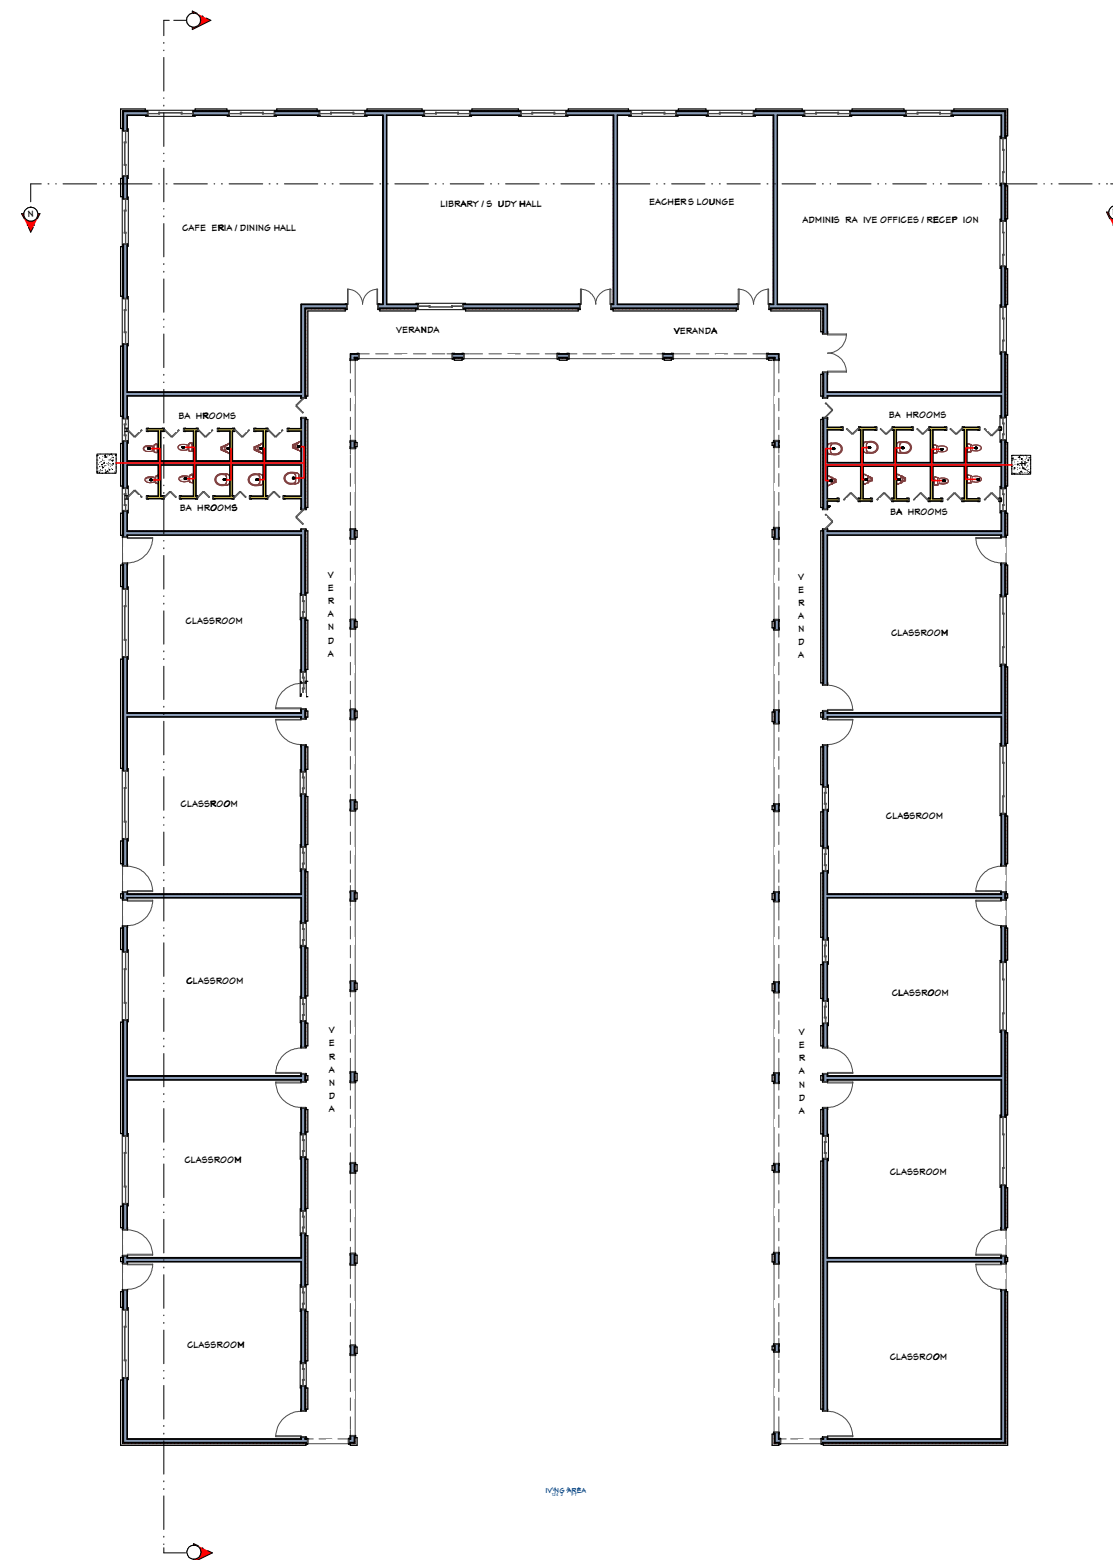


|                                                                          |                                 |                                        |                    |                                                           |               |          |                                                                           |                         |              |           |
|--------------------------------------------------------------------------|---------------------------------|----------------------------------------|--------------------|-----------------------------------------------------------|---------------|----------|---------------------------------------------------------------------------|-------------------------|--------------|-----------|
| PROJECT LOCATION:                                                        | PLOT SCALE                      | N / A                                  | Drawing Provide By | CLIENTS:                                                  | DWG. TITLE:   | F.A./RTE | SECTION                                                                   | Date : November 2 ,2024 | TOTAL SHEETS | SHEET NO. |
| Bolahun City<br>Wanhassah District<br>Lofa County<br>Republic Of Liberia | DRAWN<br>DESIGNED:<br>ARCHITECT | Trust Management<br>Construction Group |                    | Bolahunworldwide- USA<br>St. Agnes Reconstruction Project | PLUMBING PLAN | NOTE:    | ALL DIMENSIONS ARE IN FEET & INCHES<br>AND SHOULD BE VERIFIED ON THE SITE |                         | 20           | 10        |

 
| PLUMBING SYMBOLS    |                                                                                       |
|---------------------|---------------------------------------------------------------------------------------|
| Soil Or Waste Pipe  |    |
| Vent                |    |
| Storm Drain         |    |
| Cold Water          |    |
| Hot Water           |    |
| Fire Line           |    |
| Sprinkler           |   |
| Gas, Low Pressure   |  |
| Clay Tile           |  |
| Flange gate Valve   |  |
| Flange Globe Valve  |  |
| Flange Connections  |  |
| Screwed Connections |  |
| Welded Connections  |  |
| Compressed Air      |  |

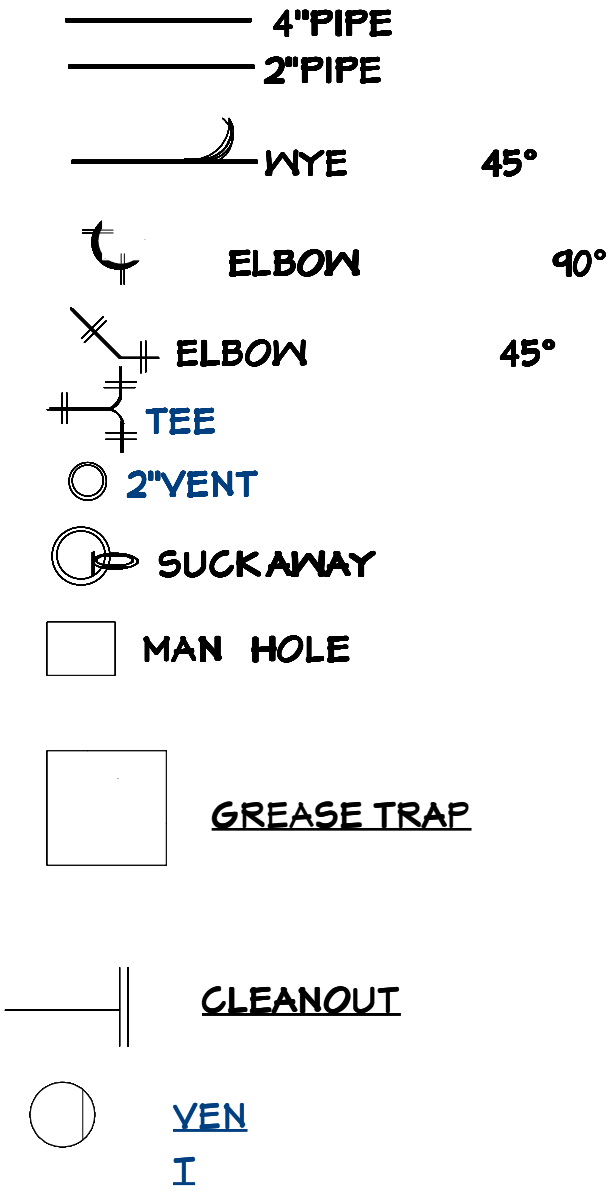


|                                                                          |            |                                        |                    |                                                           |                  |          |                                                                           |                         |              |           |
|--------------------------------------------------------------------------|------------|----------------------------------------|--------------------|-----------------------------------------------------------|------------------|----------|---------------------------------------------------------------------------|-------------------------|--------------|-----------|
| PROJECT LOCATION:                                                        | PLOT SCALE | N / A                                  | Drawing Provide By | CLIENTS:                                                  | DWG. TITLE:      | F.A./RTE | SECTION                                                                   | Date : November 2 ,2024 | TOTAL SHEETS | SHEET NO. |
| Bolahun City<br>Wanhassah District<br>Lofa County<br>Republic Of Liberia | DRAWN      | Trust Management<br>Construction Group |                    | Bolahunworldwide- USA<br>St. Agnes Reconstruction Project | PLUMBING LEGENDS |          |                                                                           |                         | 20           | 11        |
|                                                                          | DESIGNED:  |                                        |                    |                                                           |                  |          |                                                                           |                         |              |           |
|                                                                          | ARCHITECT  |                                        |                    |                                                           |                  | NOTE:    | ALL DIMENSIONS ARE IN FEET & INCHES<br>AND SHOULD BE VERIFIED ON THE SITE |                         |              |           |

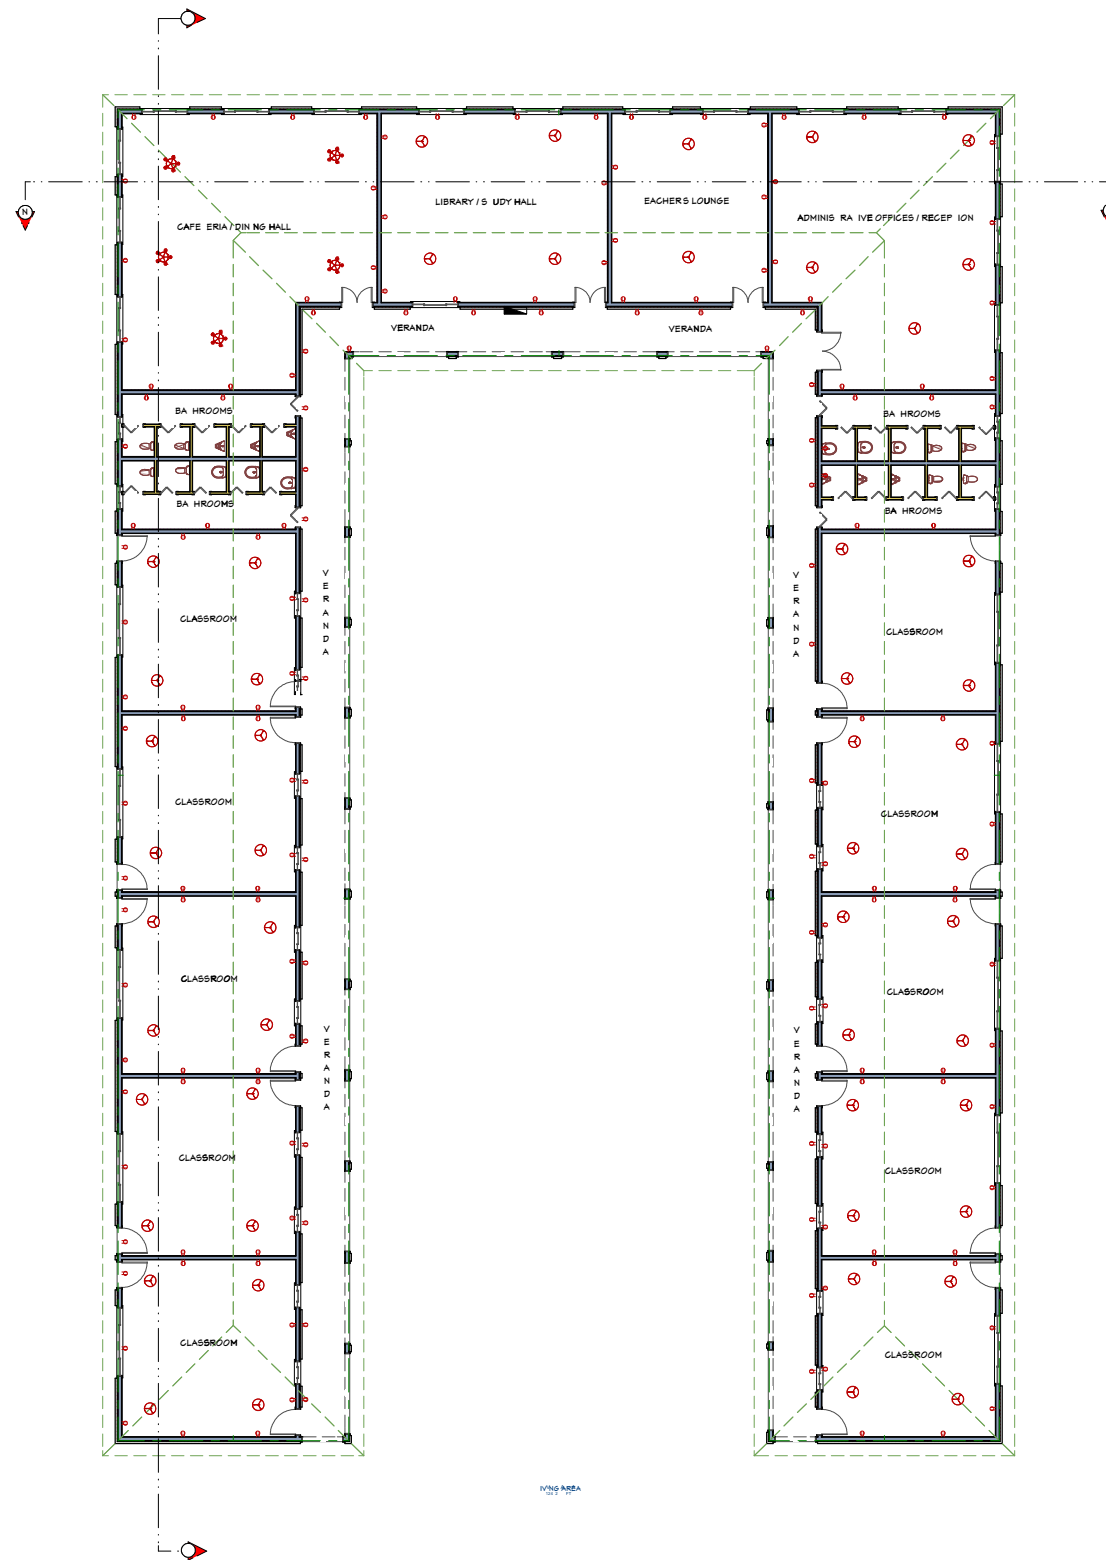

| PROJECT LOCATION:                                                        | PLOT SCALE                      | N / A                                  | Drawing Provide By | CLIENTS:                                                  | DWG. TITLE:     | F.A./RTE | SECTION                                                                   | Date : November 2 ,2024 | TOTAL SHEETS | SHEET NO. |
|--------------------------------------------------------------------------|---------------------------------|----------------------------------------|--------------------|-----------------------------------------------------------|-----------------|----------|---------------------------------------------------------------------------|-------------------------|--------------|-----------|
| Bolahun City<br>Wanhassah District<br>Lofa County<br>Republic Of Liberia | DRAWN<br>DESIGNED:<br>ARCHITECT | Trust Management<br>Construction Group |                    | Bolahunworldwide- USA<br>St. Agnes Reconstruction Project | ELECTRICAL PLAN | NOTE:    | ALL DIMENSIONS ARE IN FEET & INCHES<br>AND SHOULD BE VERIFIED ON THE SITE |                         | 20           | 12        |

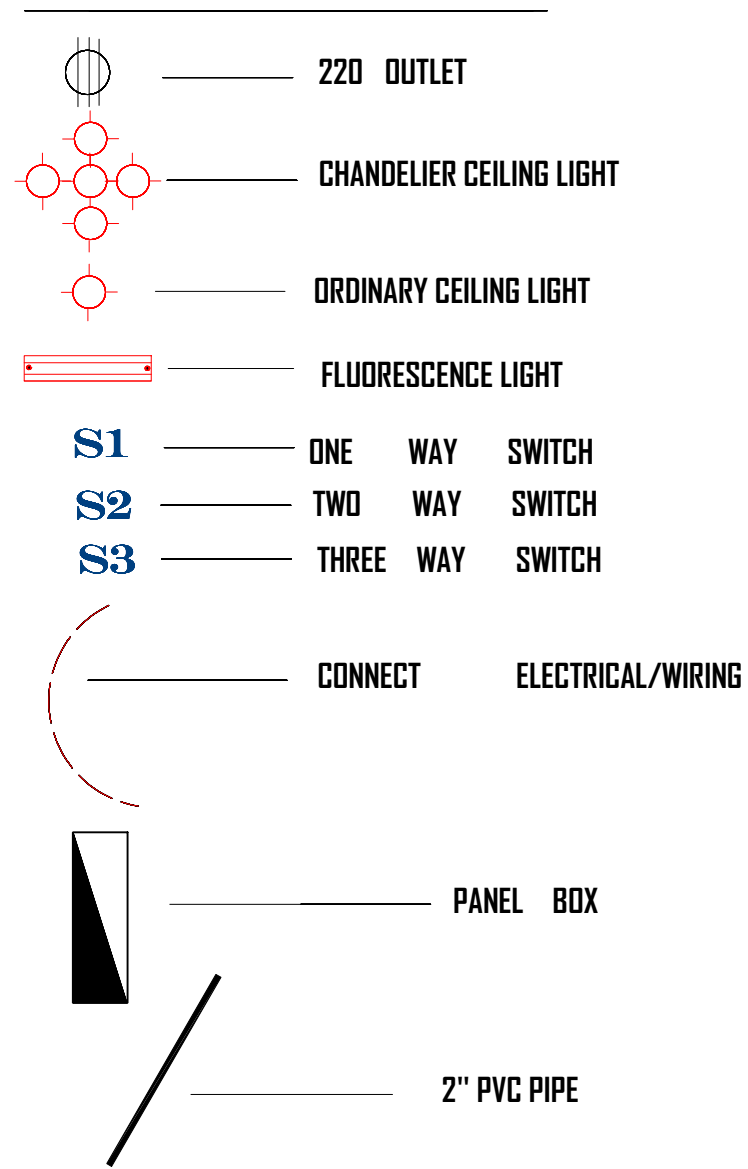


| ELECTRICAL - DATA - AUDIO LEGEND |                                                                                   |
|----------------------------------|-----------------------------------------------------------------------------------|
| SYMBOL                           | DESCRIPTION                                                                       |
|                                  | Ceiling Fan                                                                       |
|                                  | Ventilation Fans: Ceiling Mounted, Wall Mounted                                   |
|                                  | Ceiling Mounted Light Fixtures: Surface/Pendant, Recessed, Heat Lamp, Low Voltage |
|                                  | Wall Mounted Light Fixtures: Flush Mounted, Wall Sconce                           |
|                                  | Chandelier Light Fixture                                                          |
|                                  | Fluorescent Light Fixture                                                         |
|                                  | 240V Receptacle                                                                   |
|                                  | 110V Receptacles: Duplex, Weather Proof, GFCI                                     |
|                                  | Switches: Single Pole, Weather Proof, 3-Way, 4-Way                                |
|                                  | Switches: Dimmer, Timer                                                           |
|                                  | Audio Video: Control Panel, Switch                                                |
|                                  | Speakers: Ceiling Mounted, Wall Mounted                                           |
|                                  | Wall Jacks: CAT5, CAT5 + TV, TV/Cable                                             |
|                                  | Telephone Jack                                                                    |
|                                  | Intercom                                                                          |
|                                  | Thermostat                                                                        |
|                                  | Door Chime, Door Bell Button                                                      |
|                                  | Smoke Detectors: Ceiling Mounted, Wall Mounted                                    |
|                                  | Electrical Breaker Panel                                                          |

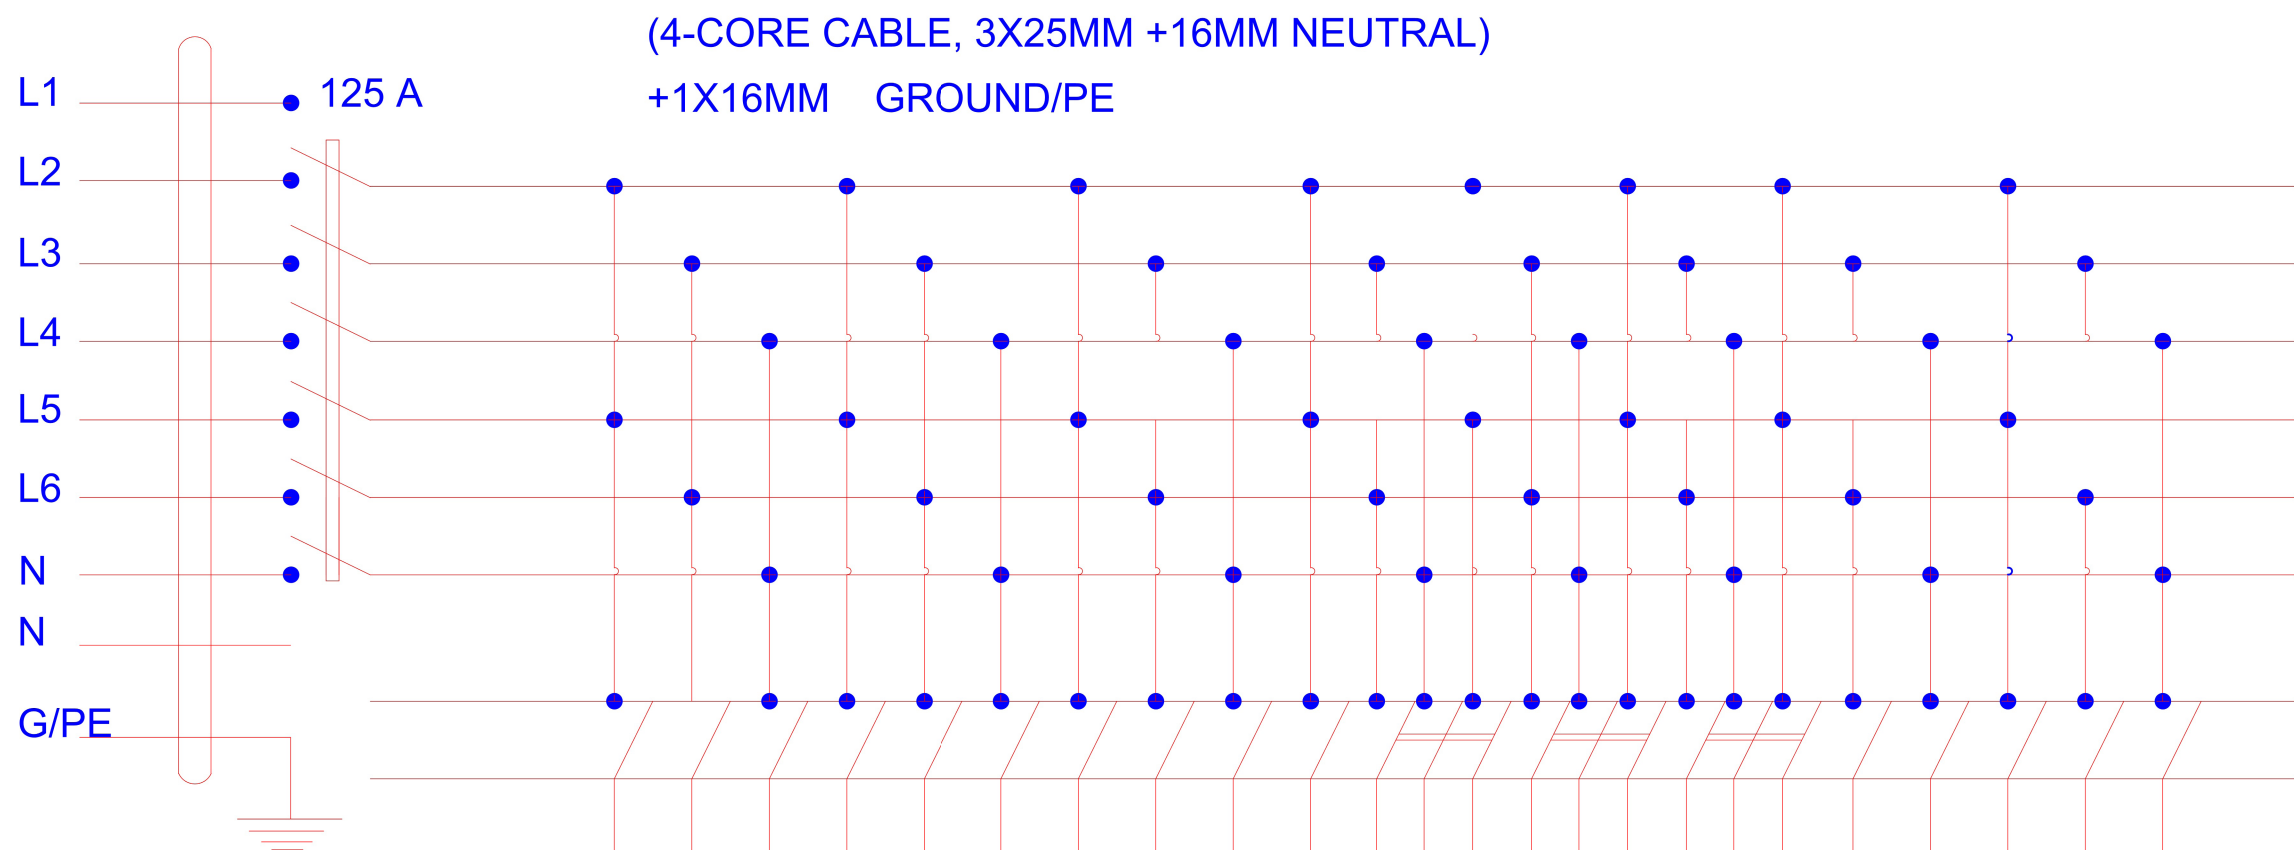


|                                            |                |--------------------------------------------|----------------|----------------|----------------|----------------|----------------|----------------|-------|-------|-------|-------|----------------|-------|-------|-------|-------|-------|-------|-------|-------|
| CIRCUIT DESIGNATION                        | P <sub>1</sub> | P <sub>2</sub> | P <sub>3</sub> | P <sub>4</sub> | P <sub>5</sub> | P <sub>6</sub> | SPARE | SPARE | SPARE | SPARE | K <sub>1</sub> | SPARE | SPARE | SPARE | SPARE | SPARE | SPARE | SPARE | SPARE |
| BRANCH CIRCUIT BREAKER<br>CAPACITY IN AMPS | 15             | 15             | 15             | 15             | 15             | 15             | —     | —     | —     | —     | —              | —     | —     | —     | —     | —     | —     | —     | —     |
| WIRE SIZE IN AWG                           | #10            | #10            | #10            | #10            | #10            | #10            | —     | —     | —     | —     | —              | —     | —     | —     | —     | —     | —     | —     | —     |

24- BREAKER PANEL (POWER)  
3-PHASE, EQUIPPED  
WITH SEPARATE NEUTRAL AND  
GROUNDING BUS BARS


| PROJECT LOCATION:                                                        | PLOT SCALE | N / A                                  | Drawing Provide By | CLIENTS:                                                  | DWG. TITLE:         | F.A./RTE | SECTION                                                                   | Date : November 2 ,2024 | TOTAL SHEETS | SHEET NO. |
|--------------------------------------------------------------------------|------------|----------------------------------------|--------------------|-----------------------------------------------------------|---------------------|----------|---------------------------------------------------------------------------|-------------------------|--------------|-----------|
| Bolahun City<br>Wanhassah District<br>Lofa County<br>Republic Of Liberia | DRAWN      | Trust Management<br>Construction Group |                    | Bolahunworldwide- USA<br>St. Agnes Reconstruction Project | PANEL BOARD DIAGRAM |          |                                                                           |                         | 20           | 14        |
|                                                                          | DESIGNED:  |                                        |                    |                                                           |                     |          |                                                                           |                         |              |           |
|                                                                          | ARCHITECT  |                                        |                    |                                                           |                     | NOTE:    | ALL DIMENSIONS ARE IN FEET & INCHES<br>AND SHOULD BE VERIFIED ON THE SITE |                         |              |           |

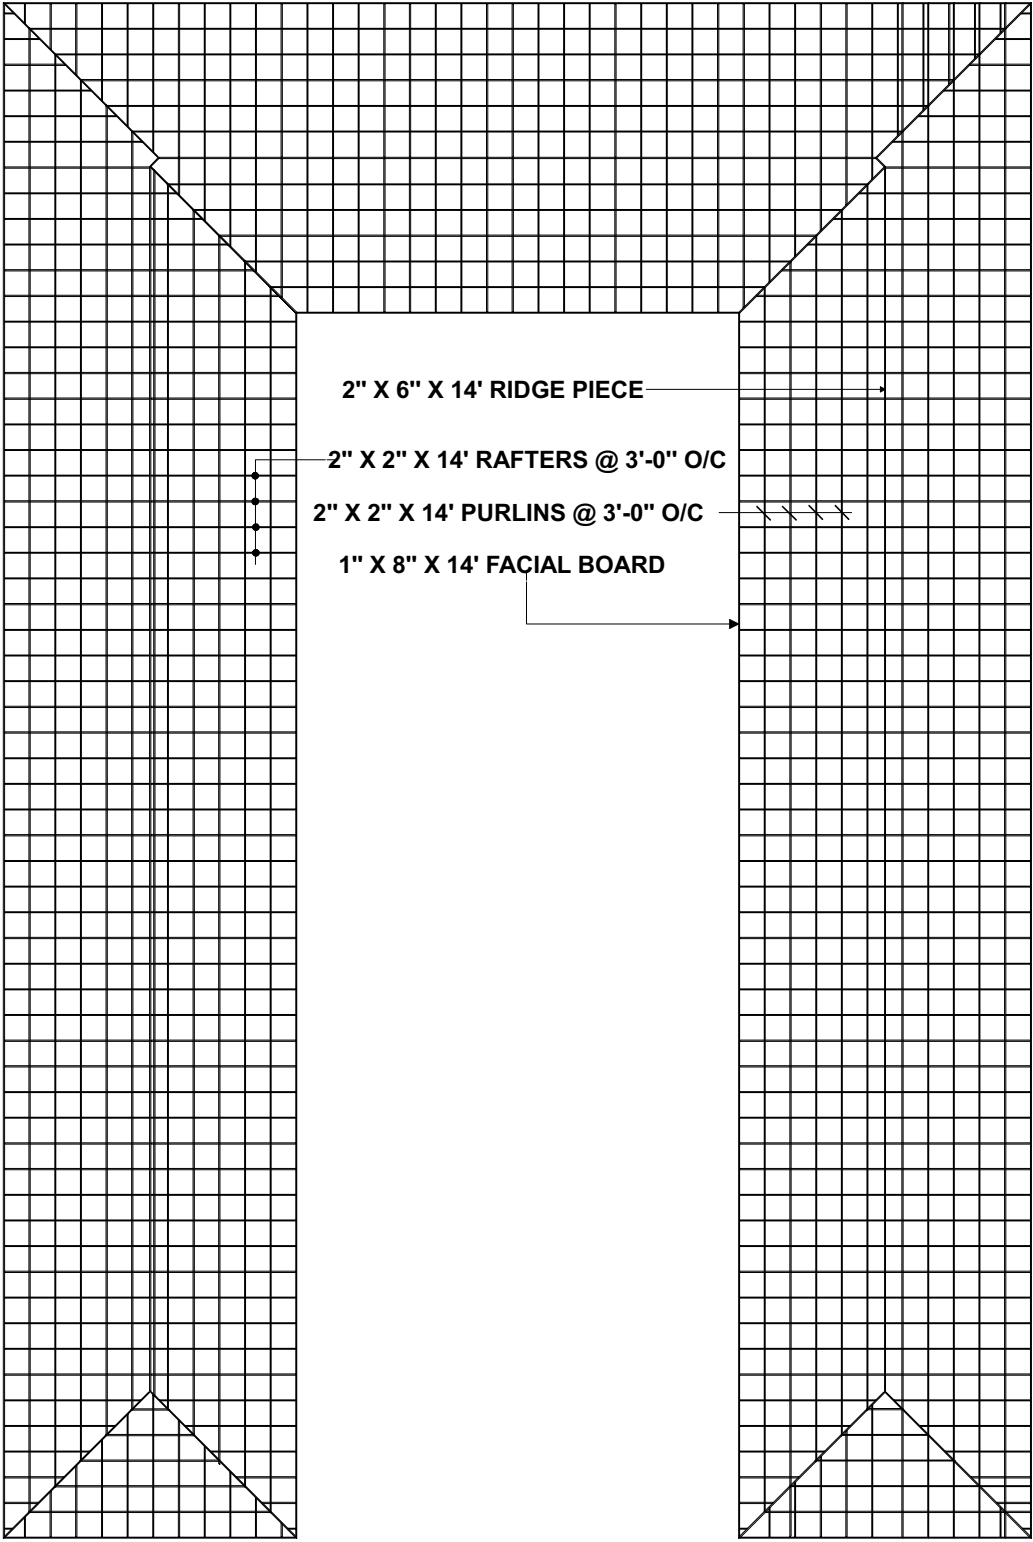


| PROJECT LOCATION:                                                        | PLOT SCALE | N / A                                  | Drawing Provide By | CLIENTS:                                                  | DWG. TITLE:       | F.A./RTE | SECTION                                                                   | Date : November 2 ,2024 | TOTAL SHEETS | SHEET NO. |
|--------------------------------------------------------------------------|------------|----------------------------------------|--------------------|-----------------------------------------------------------|-------------------|----------|---------------------------------------------------------------------------|-------------------------|--------------|-----------|
| Bolahun City<br>Wanhassah District<br>Lofa County<br>Republic Of Liberia | DRAWN      | Trust Management<br>Construction Group |                    | Bolahunworldwide- USA<br>St. Agnes Reconstruction Project | ROOF FRAMING PLAN |          |                                                                           |                         | 20           | 15        |
|                                                                          | DESIGNED:  |                                        |                    |                                                           |                   |          |                                                                           |                         |              |           |
|                                                                          | ARCHITECT  |                                        |                    |                                                           |                   | NOTE:    | ALL DIMENSIONS ARE IN FEET & INCHES<br>AND SHOULD BE VERIFIED ON THE SITE |                         |              |           |

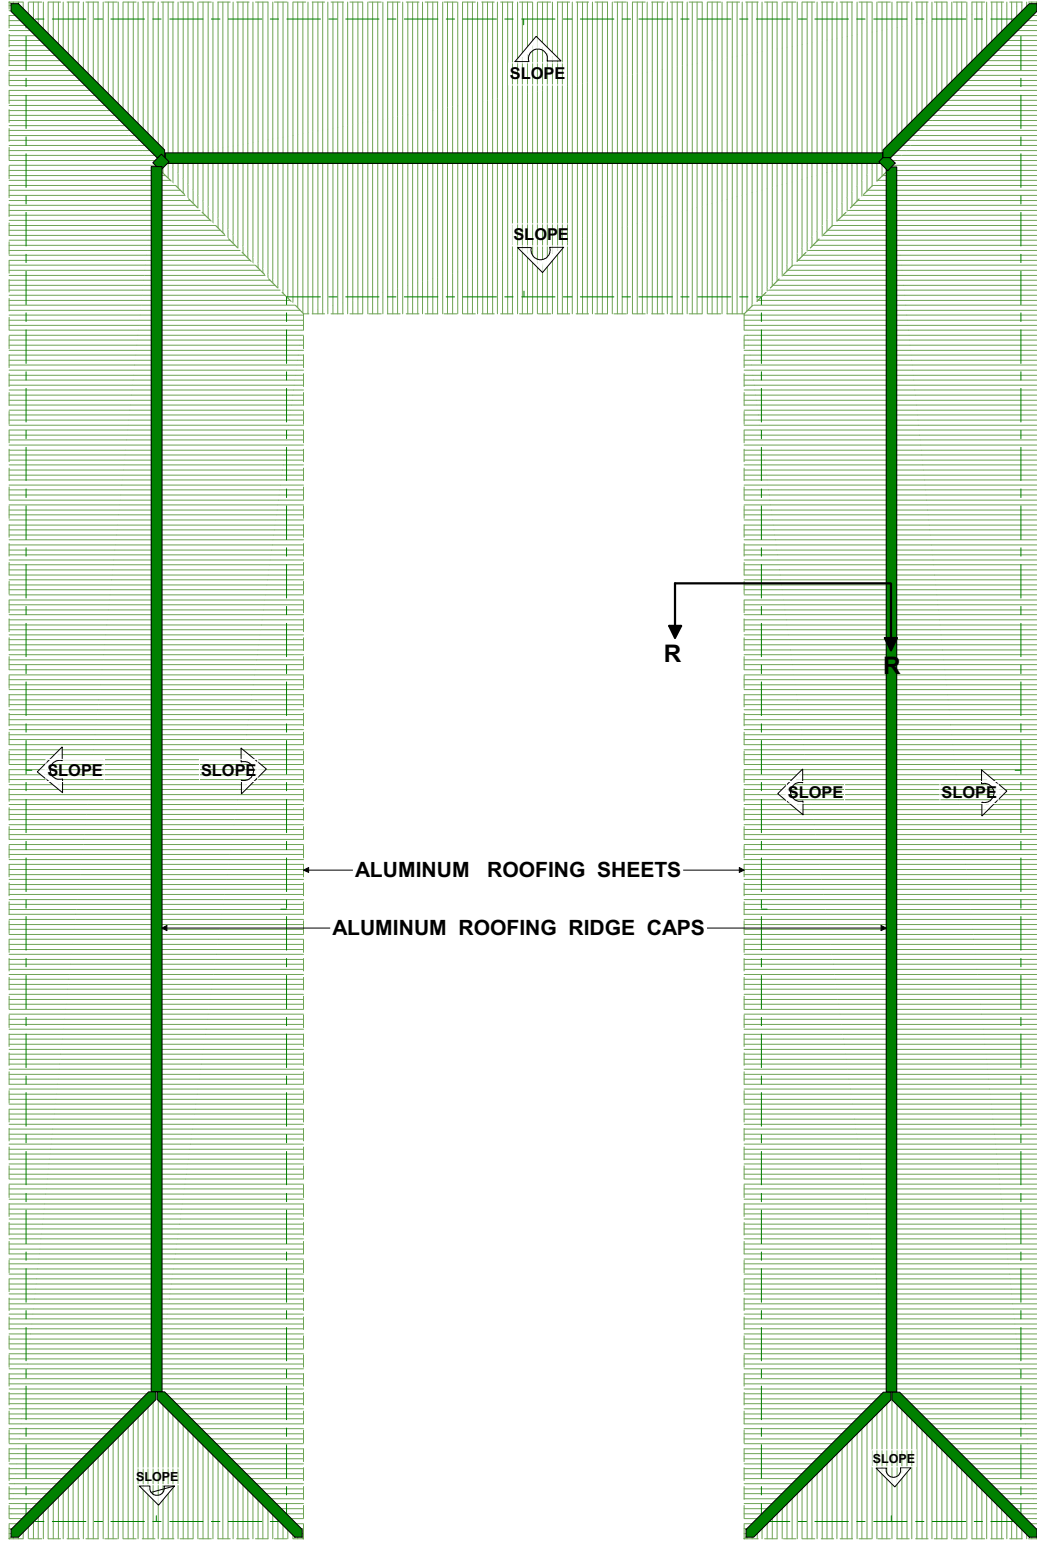


| PROJECT LOCATION:                                                        | PLOT SCALE | N / A                                  | Drawing Provide By | CLIENTS:                                                  | DWG. TITLE:        | F.A./RTE | SECTION                                                                   | Date : November 2 ,2024 | TOTAL SHEETS | SHEET NO. |
|--------------------------------------------------------------------------|------------|----------------------------------------|--------------------|-----------------------------------------------------------|--------------------|----------|---------------------------------------------------------------------------|-------------------------|--------------|-----------|
| Bolahun City<br>Wanhassah District<br>Lofa County<br>Republic Of Liberia | DRAWN      | Trust Management<br>Construction Group |                    | Bolahunworldwide- USA<br>St. Agnes Reconstruction Project | ROOF SHEETING PLAN |          |                                                                           |                         | 20           | 16        |
|                                                                          | DESIGNED:  |                                        |                    |                                                           |                    | NOTE:    | ALL DIMENSIONS ARE IN FEET & INCHES<br>AND SHOULD BE VERIFIED ON THE SITE |                         |              |           |
|                                                                          | ARCHITECT  |                                        |                    |                                                           |                    |          |                                                                           |                         |              |           |

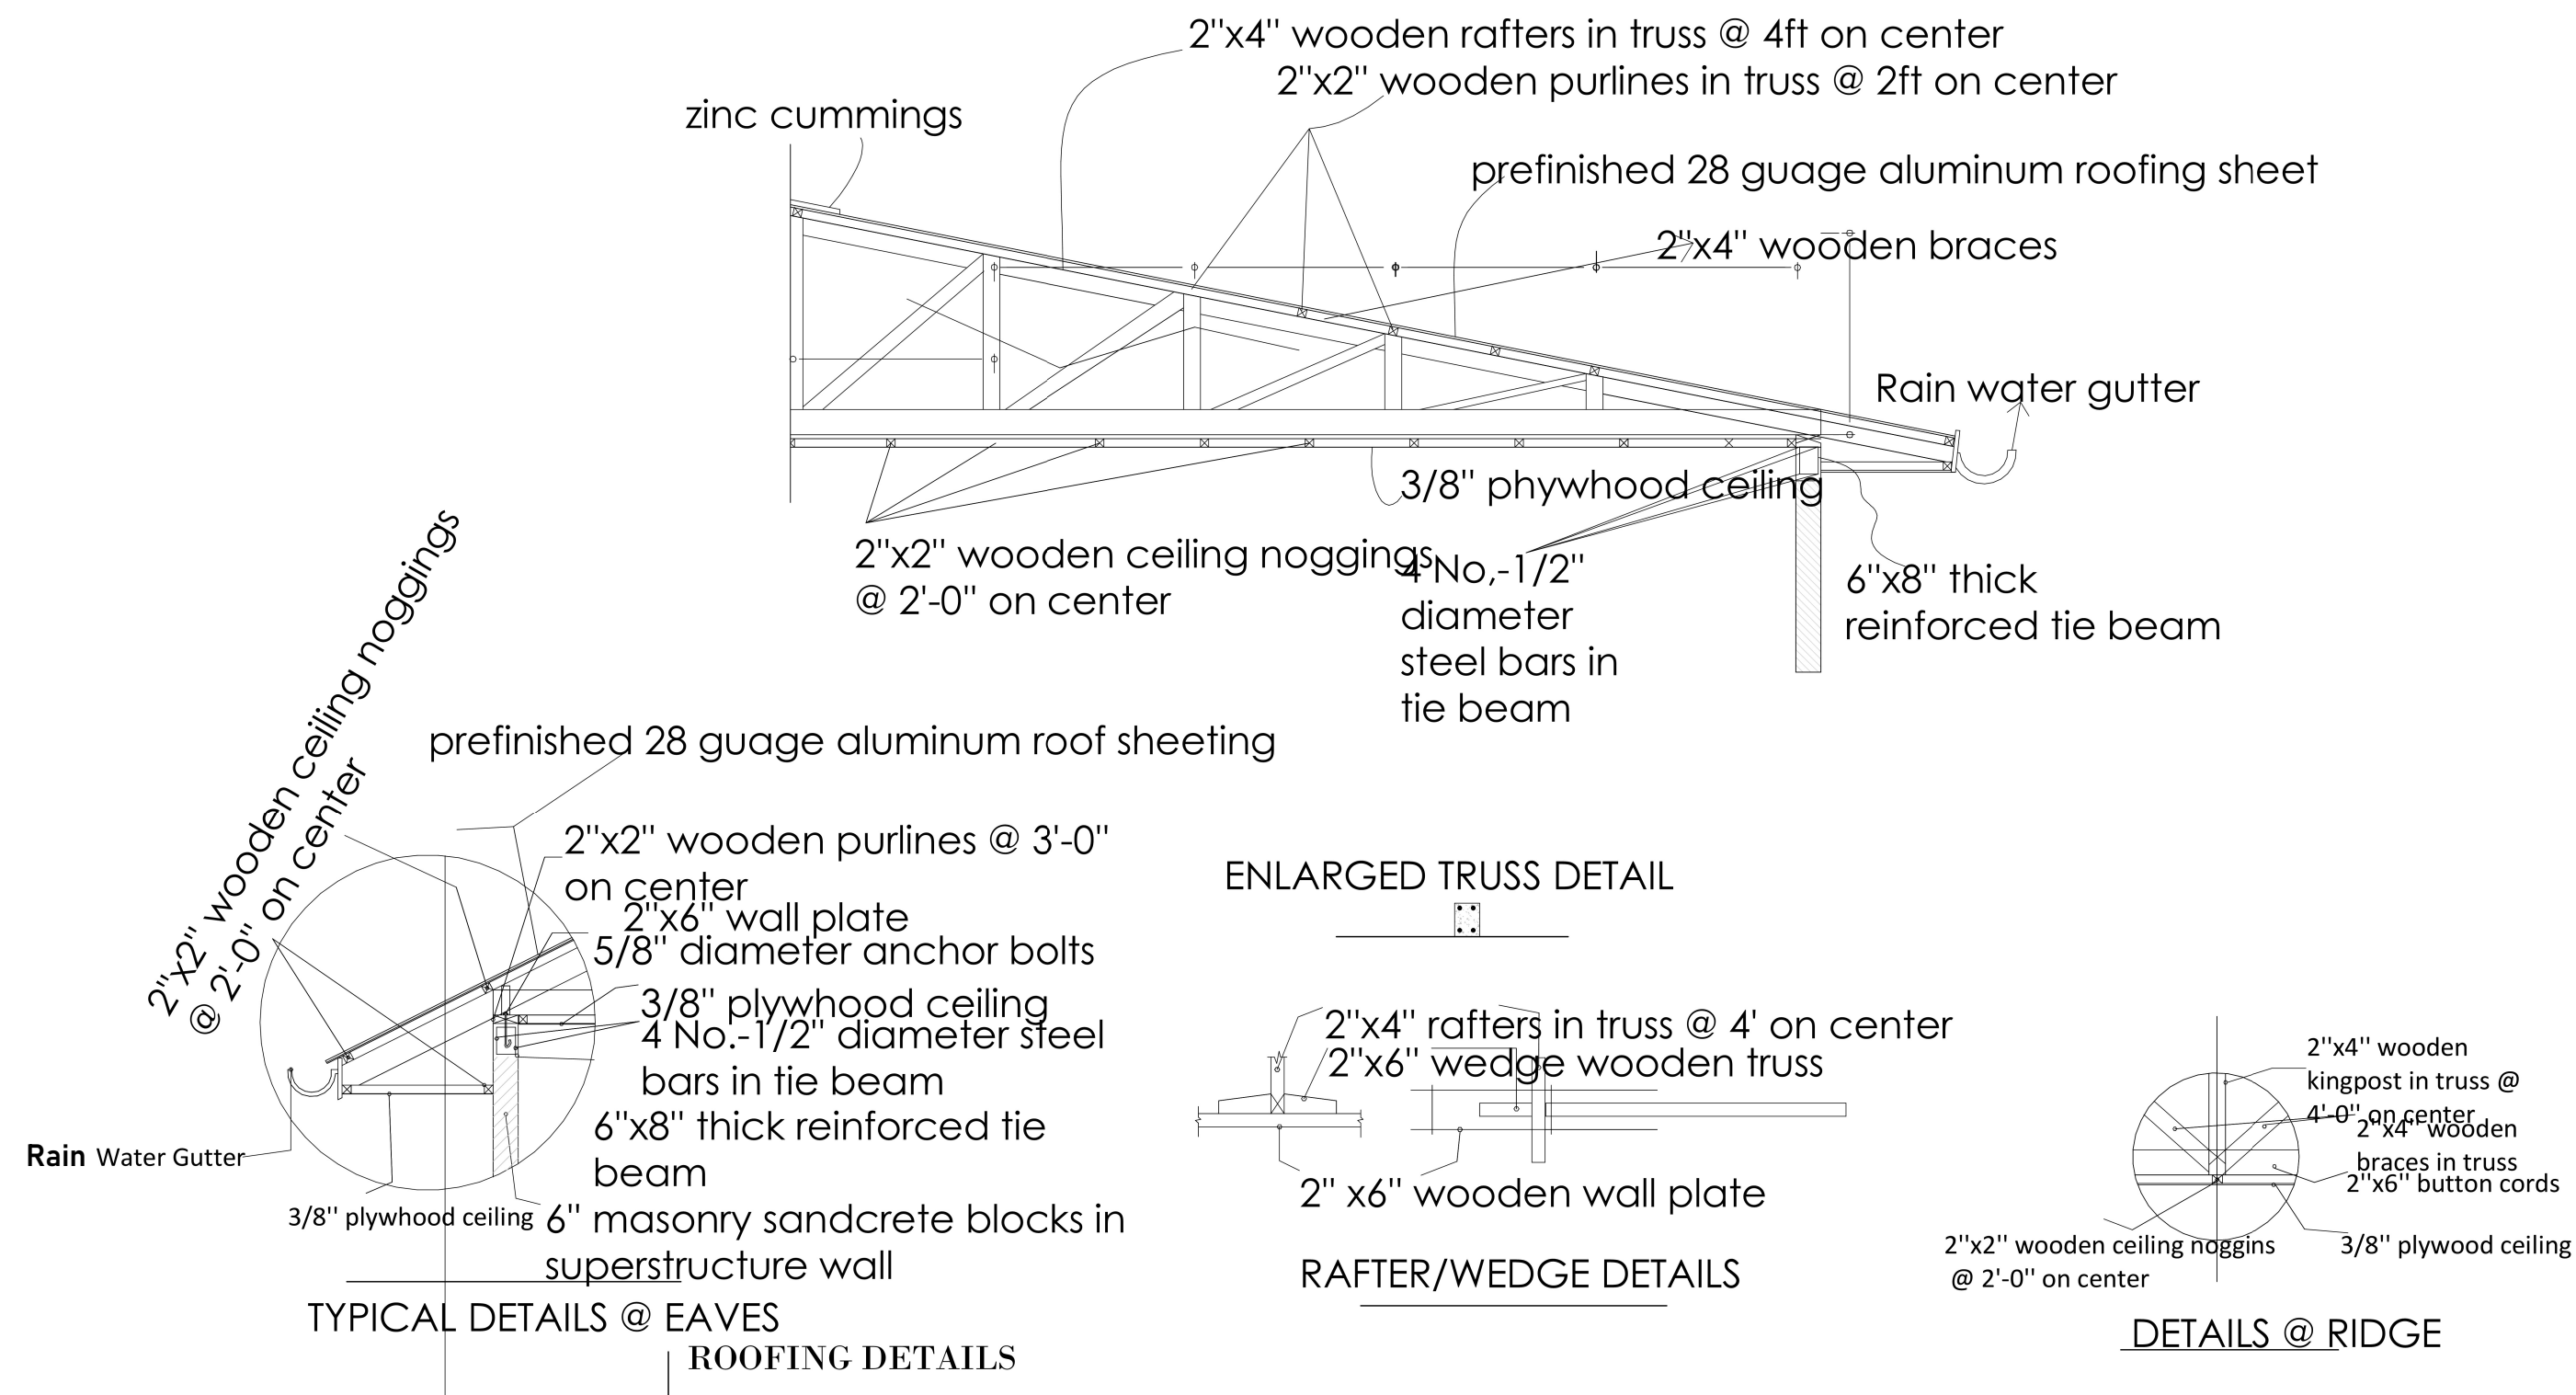

| PROJECT LOCATION:                                                        | PLOT SCALE                      | N / A                                  | Drawing Provide By                                        | CLIENTS:                | DWG. TITLE: | F.A./RTE                                                                  | SECTION | Date : November 2 ,2024 | TOTAL SHEETS | SHEET NO. |
|--------------------------------------------------------------------------|---------------------------------|----------------------------------------|-----------------------------------------------------------|-------------------------|-------------|---------------------------------------------------------------------------|---------|-------------------------|--------------|-----------|
| Bolahun City<br>Wanhassah District<br>Lofa County<br>Republic Of Liberia | DRAWN<br>DESIGNED:<br>ARCHITECT | Trust Management<br>Construction Group | Bolahunworldwide- USA<br>St. Agnes Reconstruction Project | TYPICAL ROOFING DETAILS | NOTE:       | ALL DIMENSIONS ARE IN FEET & INCHES<br>AND SHOULD BE VERIFIED ON THE SITE |         |                         | 20           | 17        |

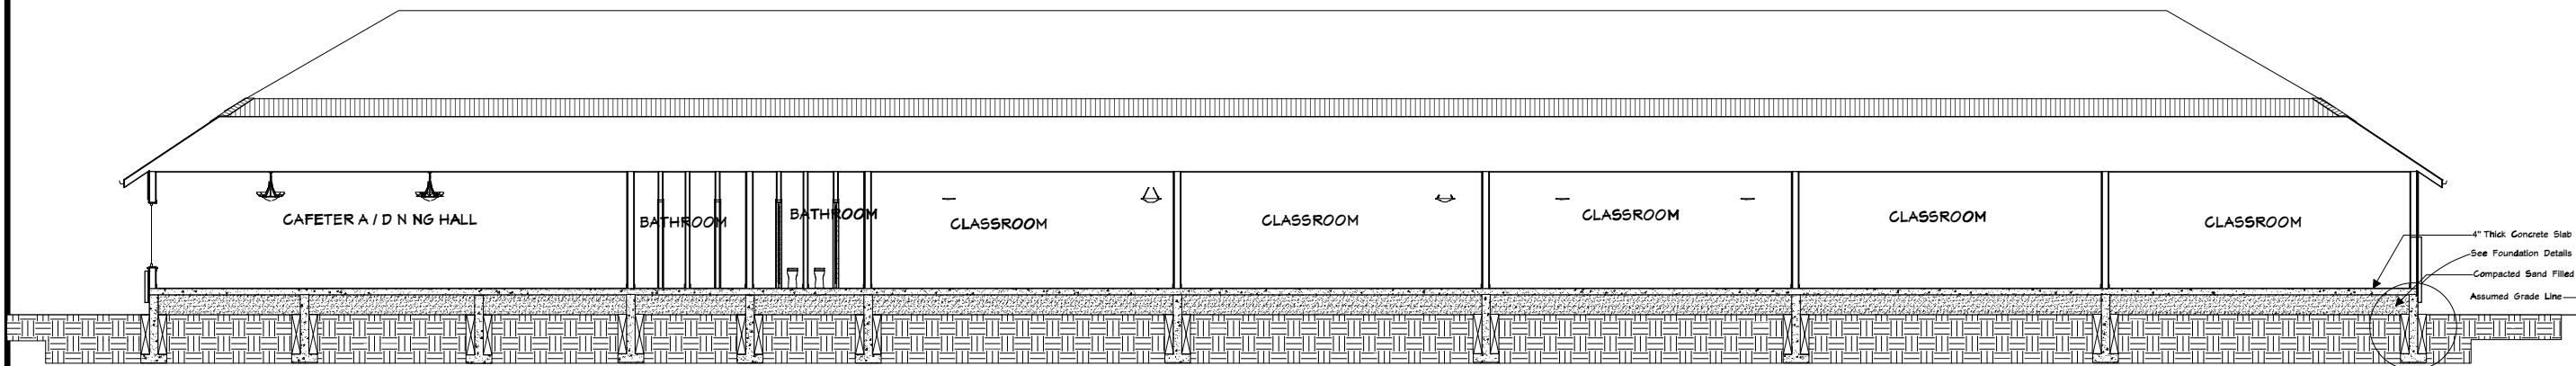


| PROJECT LOCATION:                                                        | PLOT SCALE | N / A                                  | Drawing Provide By | CLIENTS:                                                  | DWG. TITLE:                     | F.A./RTE | SECTION                                                                   | Date : November 2 ,2024 | TOTAL SHEETS | SHEET NO. |
|--------------------------------------------------------------------------|------------|----------------------------------------|--------------------|-----------------------------------------------------------|---------------------------------|----------|---------------------------------------------------------------------------|-------------------------|--------------|-----------|
| Bolahun City<br>Wanhassah District<br>Lofa County<br>Republic Of Liberia | DRAWN      | Trust Management<br>Construction Group |                    | Bolahunworldwide- USA<br>St. Agnes Reconstruction Project | LONGITUDINAL SECTION<br>@ T - T |          |                                                                           |                         | 20           | 18        |
|                                                                          | DESIGNED:  |                                        |                    |                                                           |                                 |          |                                                                           |                         |              |           |
|                                                                          | ARCHITECT  |                                        |                    |                                                           |                                 | NOTE:    | ALL DIMENSIONS ARE IN FEET & INCHES<br>AND SHOULD BE VERIFIED ON THE SITE |                         |              |           |

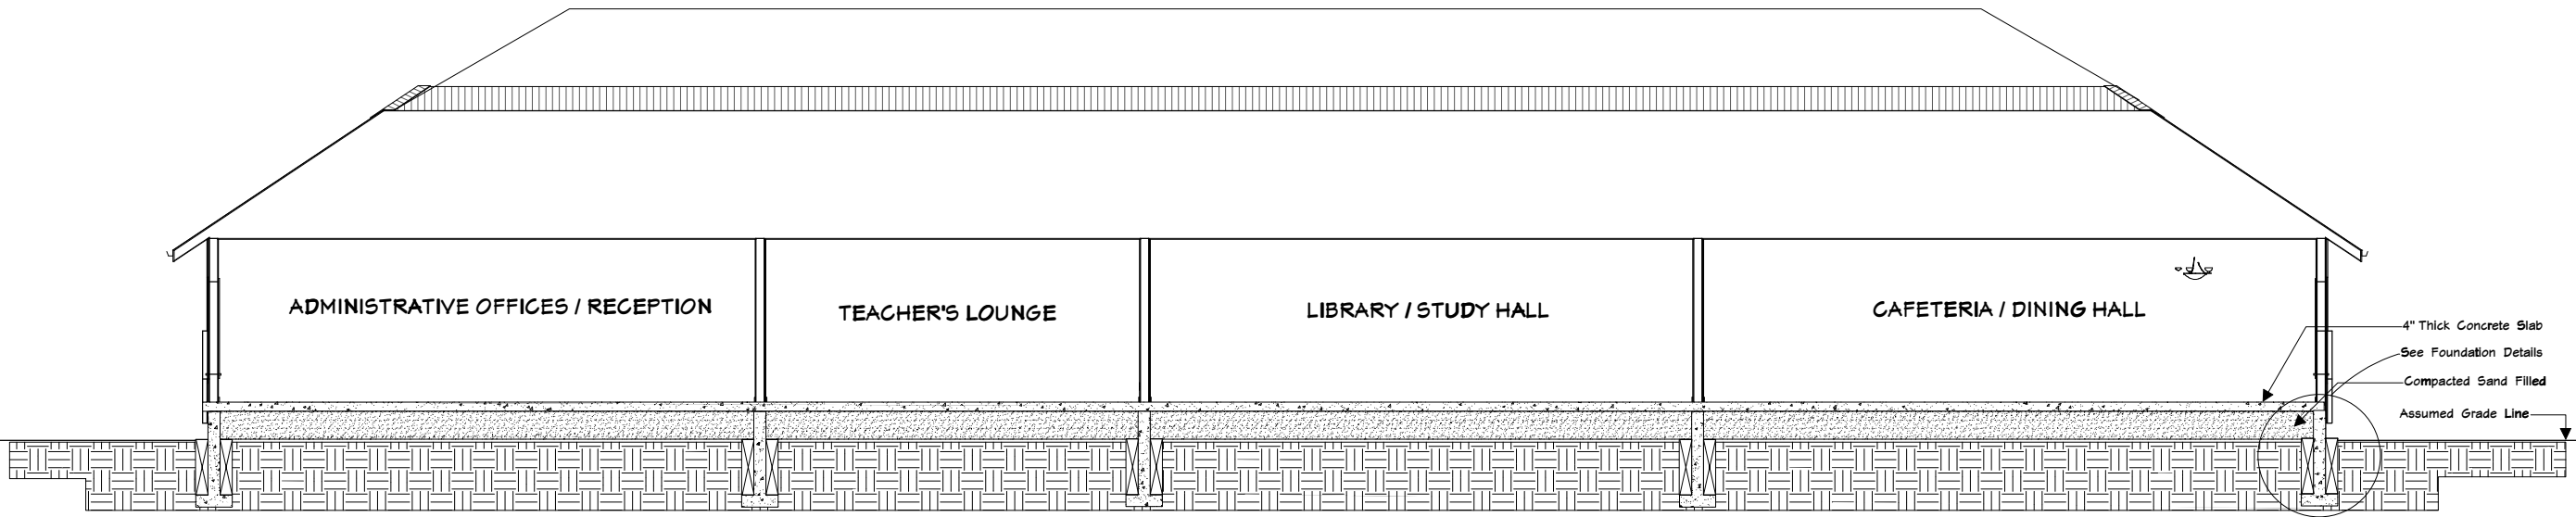


| PROJECT LOCATION:                                                        | PLOT SCALE | N / A                                  | Drawing Provide By | CLIENTS:                                                  | DWG. TITLE:           | F.A./RTE | SECTION                                                                   | Date : November 2 ,2024 | TOTAL SHEETS | SHEET NO. |
|--------------------------------------------------------------------------|------------|----------------------------------------|--------------------|-----------------------------------------------------------|-----------------------|----------|---------------------------------------------------------------------------|-------------------------|--------------|-----------|
| Bolahun City<br>Wanhassah District<br>Lofa County<br>Republic Of Liberia | DRAWN      | Trust Management<br>Construction Group |                    | Bolahunworldwide- USA<br>St. Agnes Reconstruction Project | CROSS SECTION @ N - N |          |                                                                           |                         | 20           | 19        |
|                                                                          | DESIGNED:  |                                        |                    |                                                           |                       |          |                                                                           |                         |              |           |
|                                                                          | ARCHITECT  |                                        |                    |                                                           |                       | NOTE:    | ALL DIMENSIONS ARE IN FEET & INCHES<br>AND SHOULD BE VERIFIED ON THE SITE |                         |              |           |


FRONT VIEW

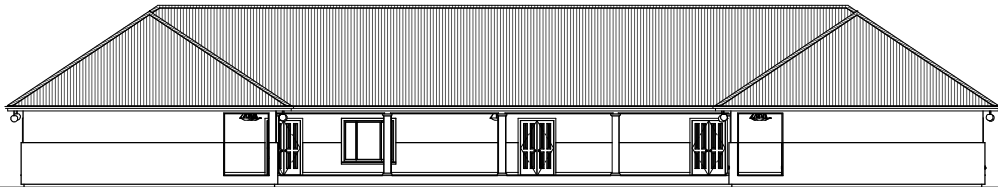


REAR VIEW

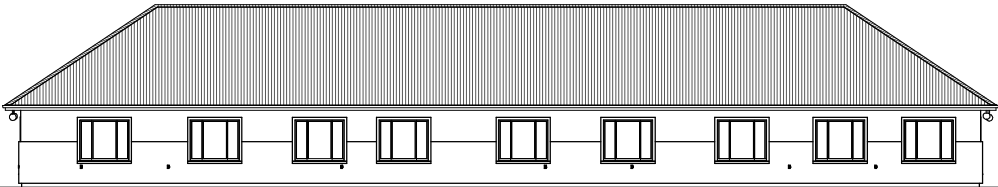

RIGHT SIDE VIEW

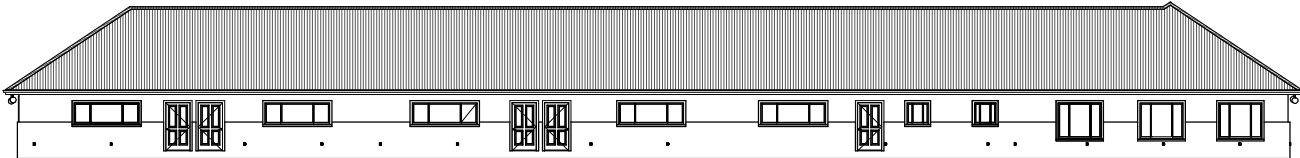

LEFT SIDE VIEW

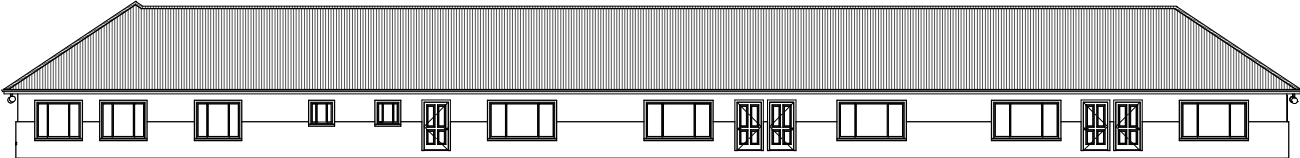

| PROJECT LOCATION:                                                        | PLOT SCALE | N / A                                  | Drawing Provide By | CLIENTS:                                                  | DWG. TITLE:    | F.A./RTE | SECTION                                                                   | Date : November 2 ,2024 | TOTAL SHEETS | SHEET NO. |
|--------------------------------------------------------------------------|------------|----------------------------------------|--------------------|-----------------------------------------------------------|----------------|----------|---------------------------------------------------------------------------|-------------------------|--------------|-----------|
| Bolahun City<br>Wanhassah District<br>Lofa County<br>Republic Of Liberia | DRAWN      | Trust Management<br>Construction Group |                    | Bolahunworldwide- USA<br>St. Agnes Reconstruction Project | ELEVATION PLAN |          |                                                                           |                         | 20           | 20        |
|                                                                          | DESIGNED:  |                                        |                    |                                                           |                |          |                                                                           |                         |              |           |
|                                                                          | ARCHITECT  |                                        |                    |                                                           |                | NOTE:    | ALL DIMENSIONS ARE IN FEET & INCHES<br>AND SHOULD BE VERIFIED ON THE SITE |                         |              |           |